


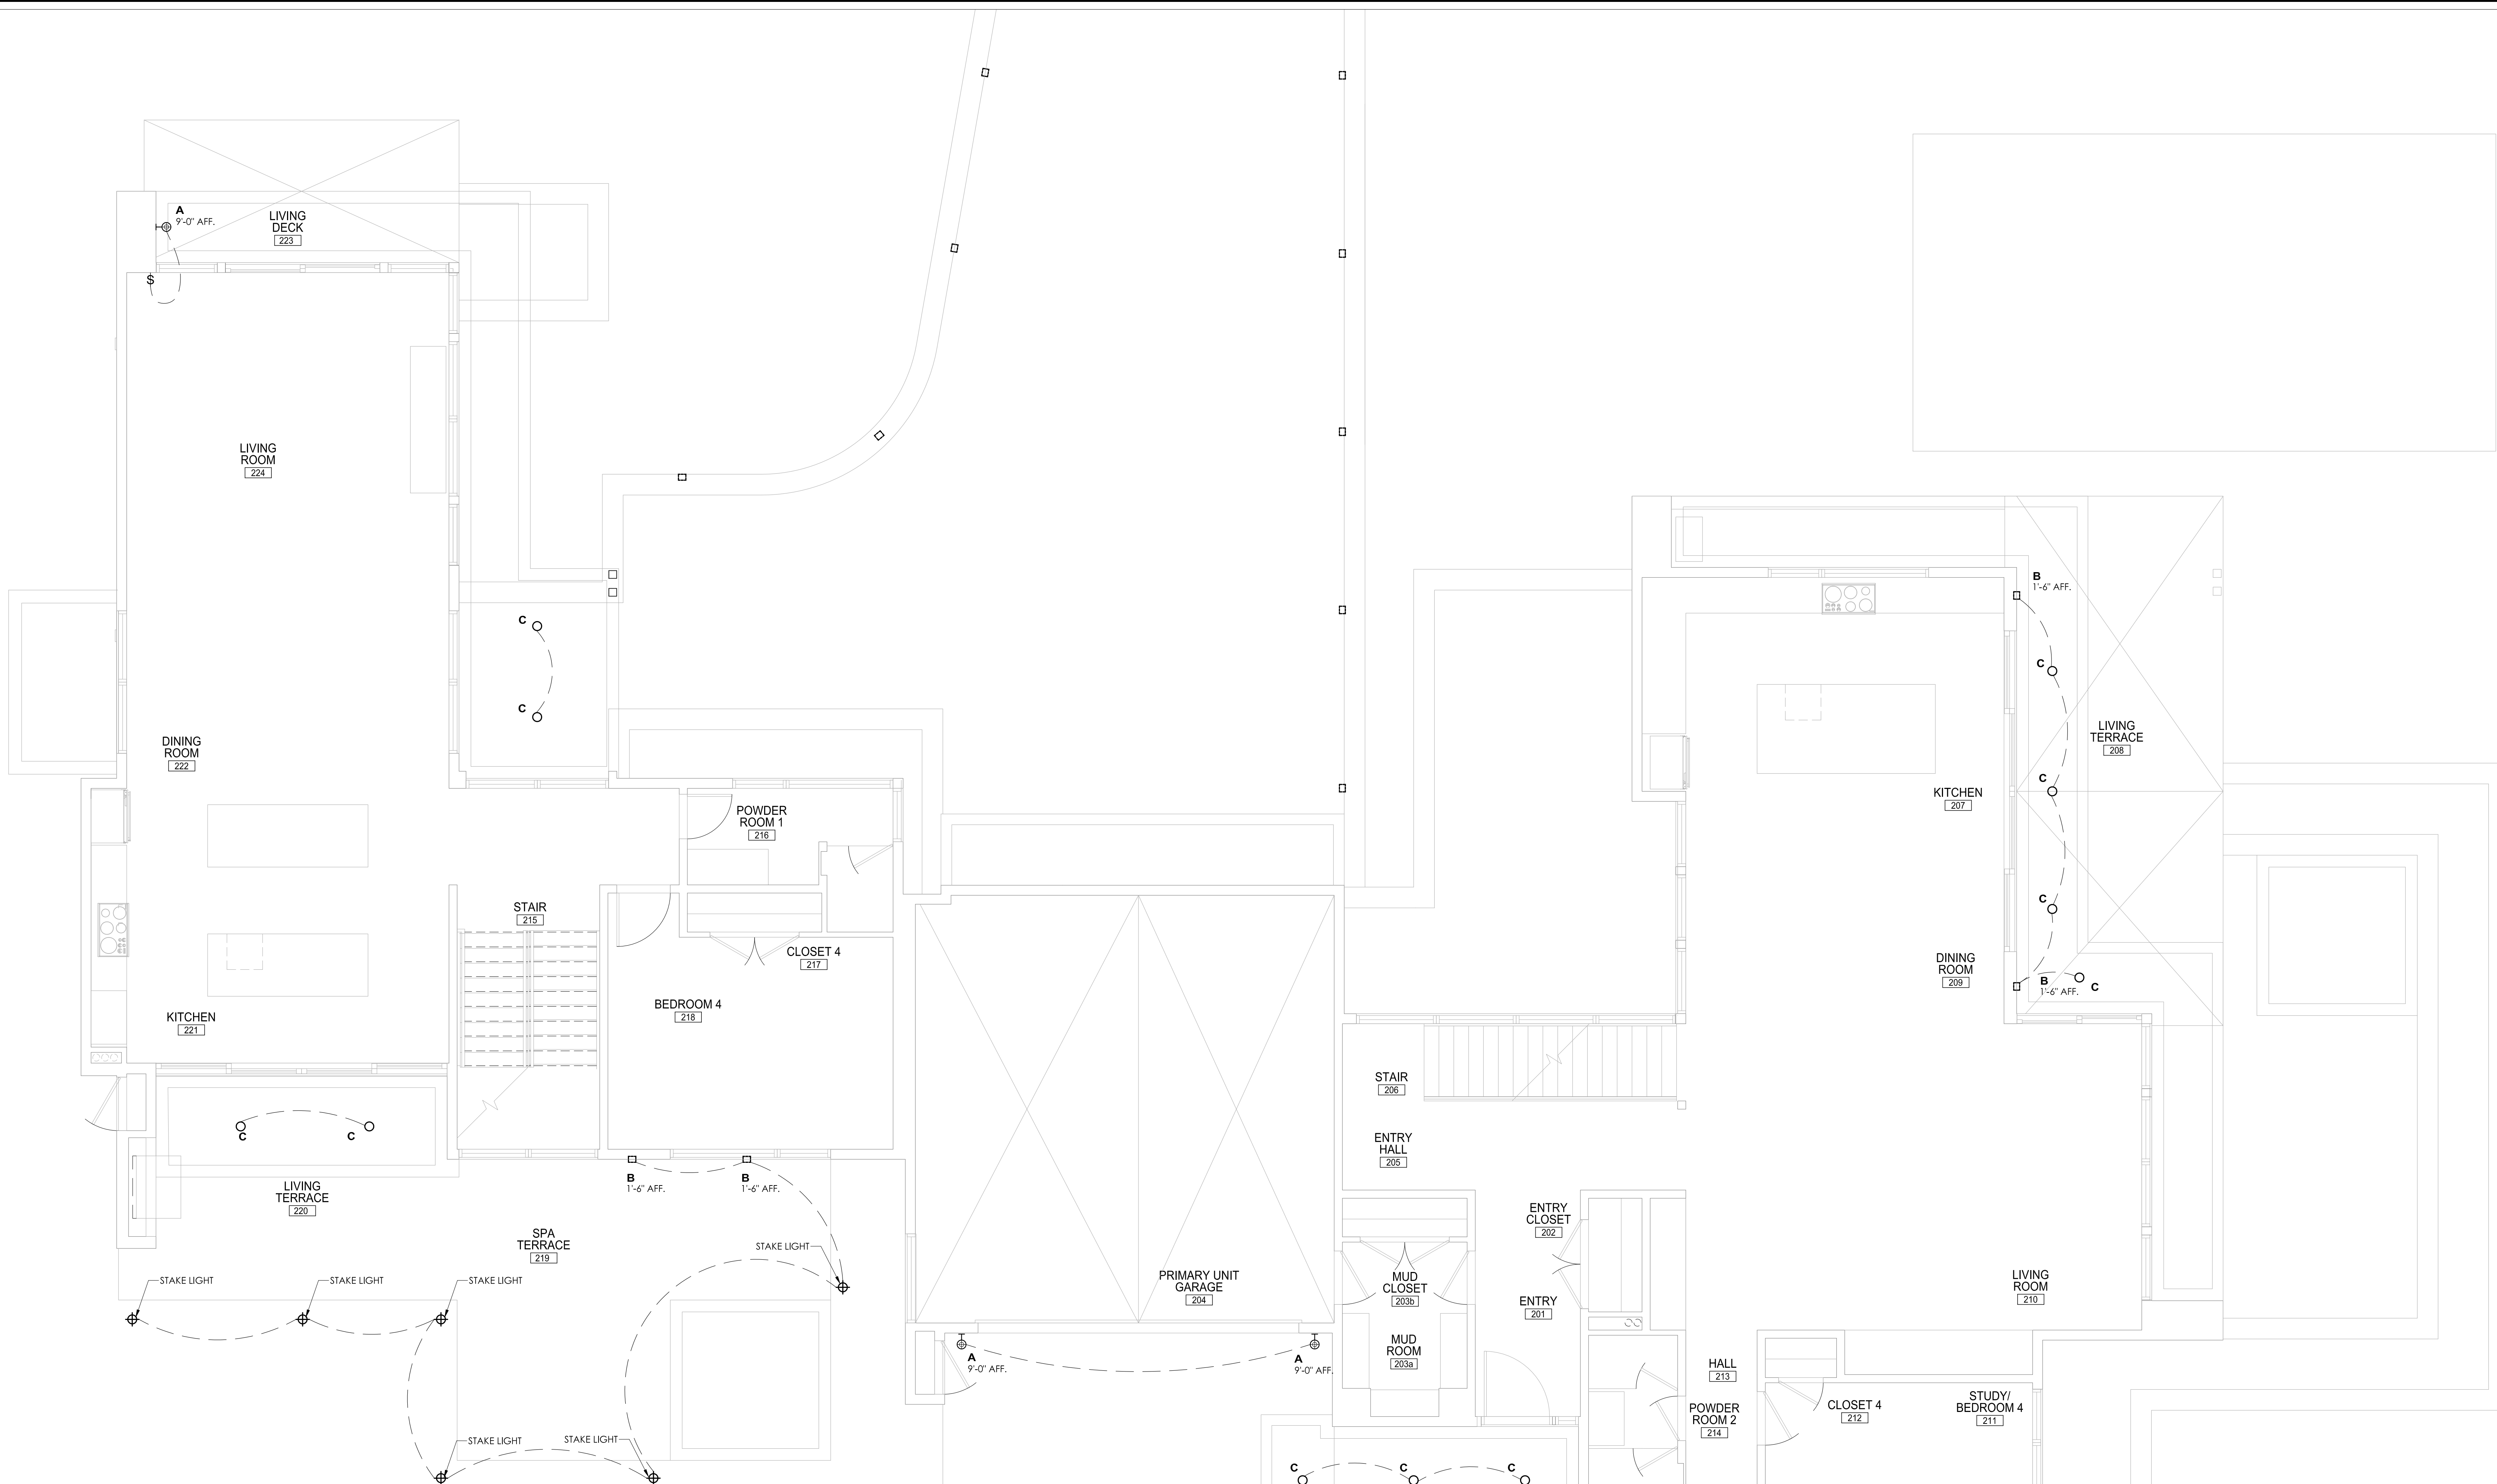

2
E2.02
SECONDARY MAIN LEVEL ELECTRICAL PLAN
SCALE: 1/4" = 1'-0"

GENERAL ELECTRICAL NOTES:

- 1) ALL RECEPTACLES IN KITCHEN TO BE GFI PROTECTED. THIS INCLUDES RECEPTACLES IN ISLANDS.
- 2) ALL RECEPTACLES AT BATHROOM COUNTERTOPS TO BE GFI PROTECTED.
- 3) ALL EXTERIOR RECEPTACLES TO BE GFI PROTECTED, AND HAVE WEATHERPROOF COVERS.
- 4) SMOKE DETECTORS TO BE INTERCONNECTED PER IRC CODE
- 5) ALL RECESSED CANS IN ROOF TO BE SEALED AIR-TIGHT
- 6) LOW VOLTAGE INTEGRATION SYSTEM THROUGHOUT HOUSE
- 7) COORDINATE ALL WINDOW SHADE POWER LOCATIONS WITH ARCHITECT
- 8) MINIMUM 75% OF NEW LIGHTING TO BE HIGH EFFICIENCY PER CURRENT IECC
- 9) BUBBLE COVERS ARE REQUIRED ON ALL EXTERIOR OUTLETS
- 10) MINIMUM OF TWO SMALL APPLICANT BRANCH CIRCUIT IN KITCHEN
- 11) ALL BRANCH CIRCUITS THAT SUPPLY 120-VOLT, SINGLE-PHASE, 15 AND 20 AMPERE OUTLETS INSTALLED IN FAMILY ROOMS, LIVING ROOMS, DINING ROOMS, PARLORS, LIBRARIES, DENIS, BEDROOMS, SUNROOMS, REC ROOMS, CLOSETS, HALLWAYS AND SIMILAR ROOMS OR AREAS SHALL BE PROTECTED BY A COMBINATION TYPE ARC-FAULT CIRCUIT INTERRUPTER INSTALLED TO PROVIDE PROTECTION OF THE BRANCH CIRCUIT PER CURRENT IRC
- 12) ALL T.V. LOCATIONS AND HEIGHTS TO BE COORDINATED WITH OWNER A/V SPECS.
- 13) NEW SECURITY SYSTEM TO BE INSTALLED
- 14) LED STRIP LIGHTING TO BE NO GREATER THAN 3000K. PROVIDE SUBMITTAL FOR APPROVAL

ELECTRICAL KEY:

	PENDANT LIGHT		SWITCH
	DIRECTIONAL LIGHT		KEY PAD SWITCH
	CEILING MOUNTED LIGHT		MULTIPLE SWITCH
	WALL MOUNTED LIGHT		DIMMER SWITCH
	WALL MOUNTED SCONCE		DUPLEX RECEPTACLE
	RECESSED CEILING LIGHT		HALF SWITCHED DUPLEX RECEPTACLE
	MONOPOINT LIGHT		GROUND FAULT DUPLEX RECEPTACLE
	RECESSED WALL LIGHT		QUAD RECEPTACLE
	UNDERCABINET LED STRIP LIGHT		THERMOSTAT
	LED LIGHT		SPECIAL DEVICE OUTLET
	LED STRIP LIGHTING		DRAPERY MOTOR
	SPECIALTY PENDANT		DUPLEX FLOOR RECEPTACLE
	TRACK LIGHT		CATEGORY 5E CABLE
	DECORATIVE WALL MOUNT		2 CATEGORY 5E CABLES
	STAKE MOUNTED LANDSCAPE LIGHT		2 RG6 COAXIAL
	PIER MOUNTED LIGHT		STRUCTURED CABLE (2 CAT 5E & 2 RG6 COAX)
	SMOKE DETECTOR		TELEPHONE OUTLET
	SPEAKER		CAMERA
	WALL MOUNTED EXHAUST FAN		
	BATHROOM EXHAUST FAN		
	JUNCTION BOX		



1
E2.02

PRIMARY MAIN LEVEL ELECTRICAL PLAN
SCALE: 1/4" = 1'-0"

FIXTURE NOTES:

- A** WALL SCONCE BY TECH LIGHTING
TAAKG-10 WALL
LED, BRONZE FINISH
(FIXTURE HAS FULL CUT-OFF)
- B** LOW WALL LIGHT BY WAC LIGHTING
WIL-LED100-C-SS (STAINLESS STEEL FINISH)
LED
(FIXTURE HAS FULL CUT-OFF)
- C** RECESSED CAN LIGHT
(FIXTURE HAS FULL CUT-OFF)


ISSUED FOR:	DATE:
TOV CONCEPTUAL REVIEW	6.25.18
UTILITY VERIFICATION	6.28.18
TOV DRB FINAL REVIEW	8.13.18

© 2018 MICHAEL SUMAN ARCHITECT, LLC.
ALL RIGHTS RESERVED.

SCALE: 1/4" = 1'-0"
DRAWN: MDS

PROJECT #: 1705
SHEET TITLE: ELECTRICAL

E2.02

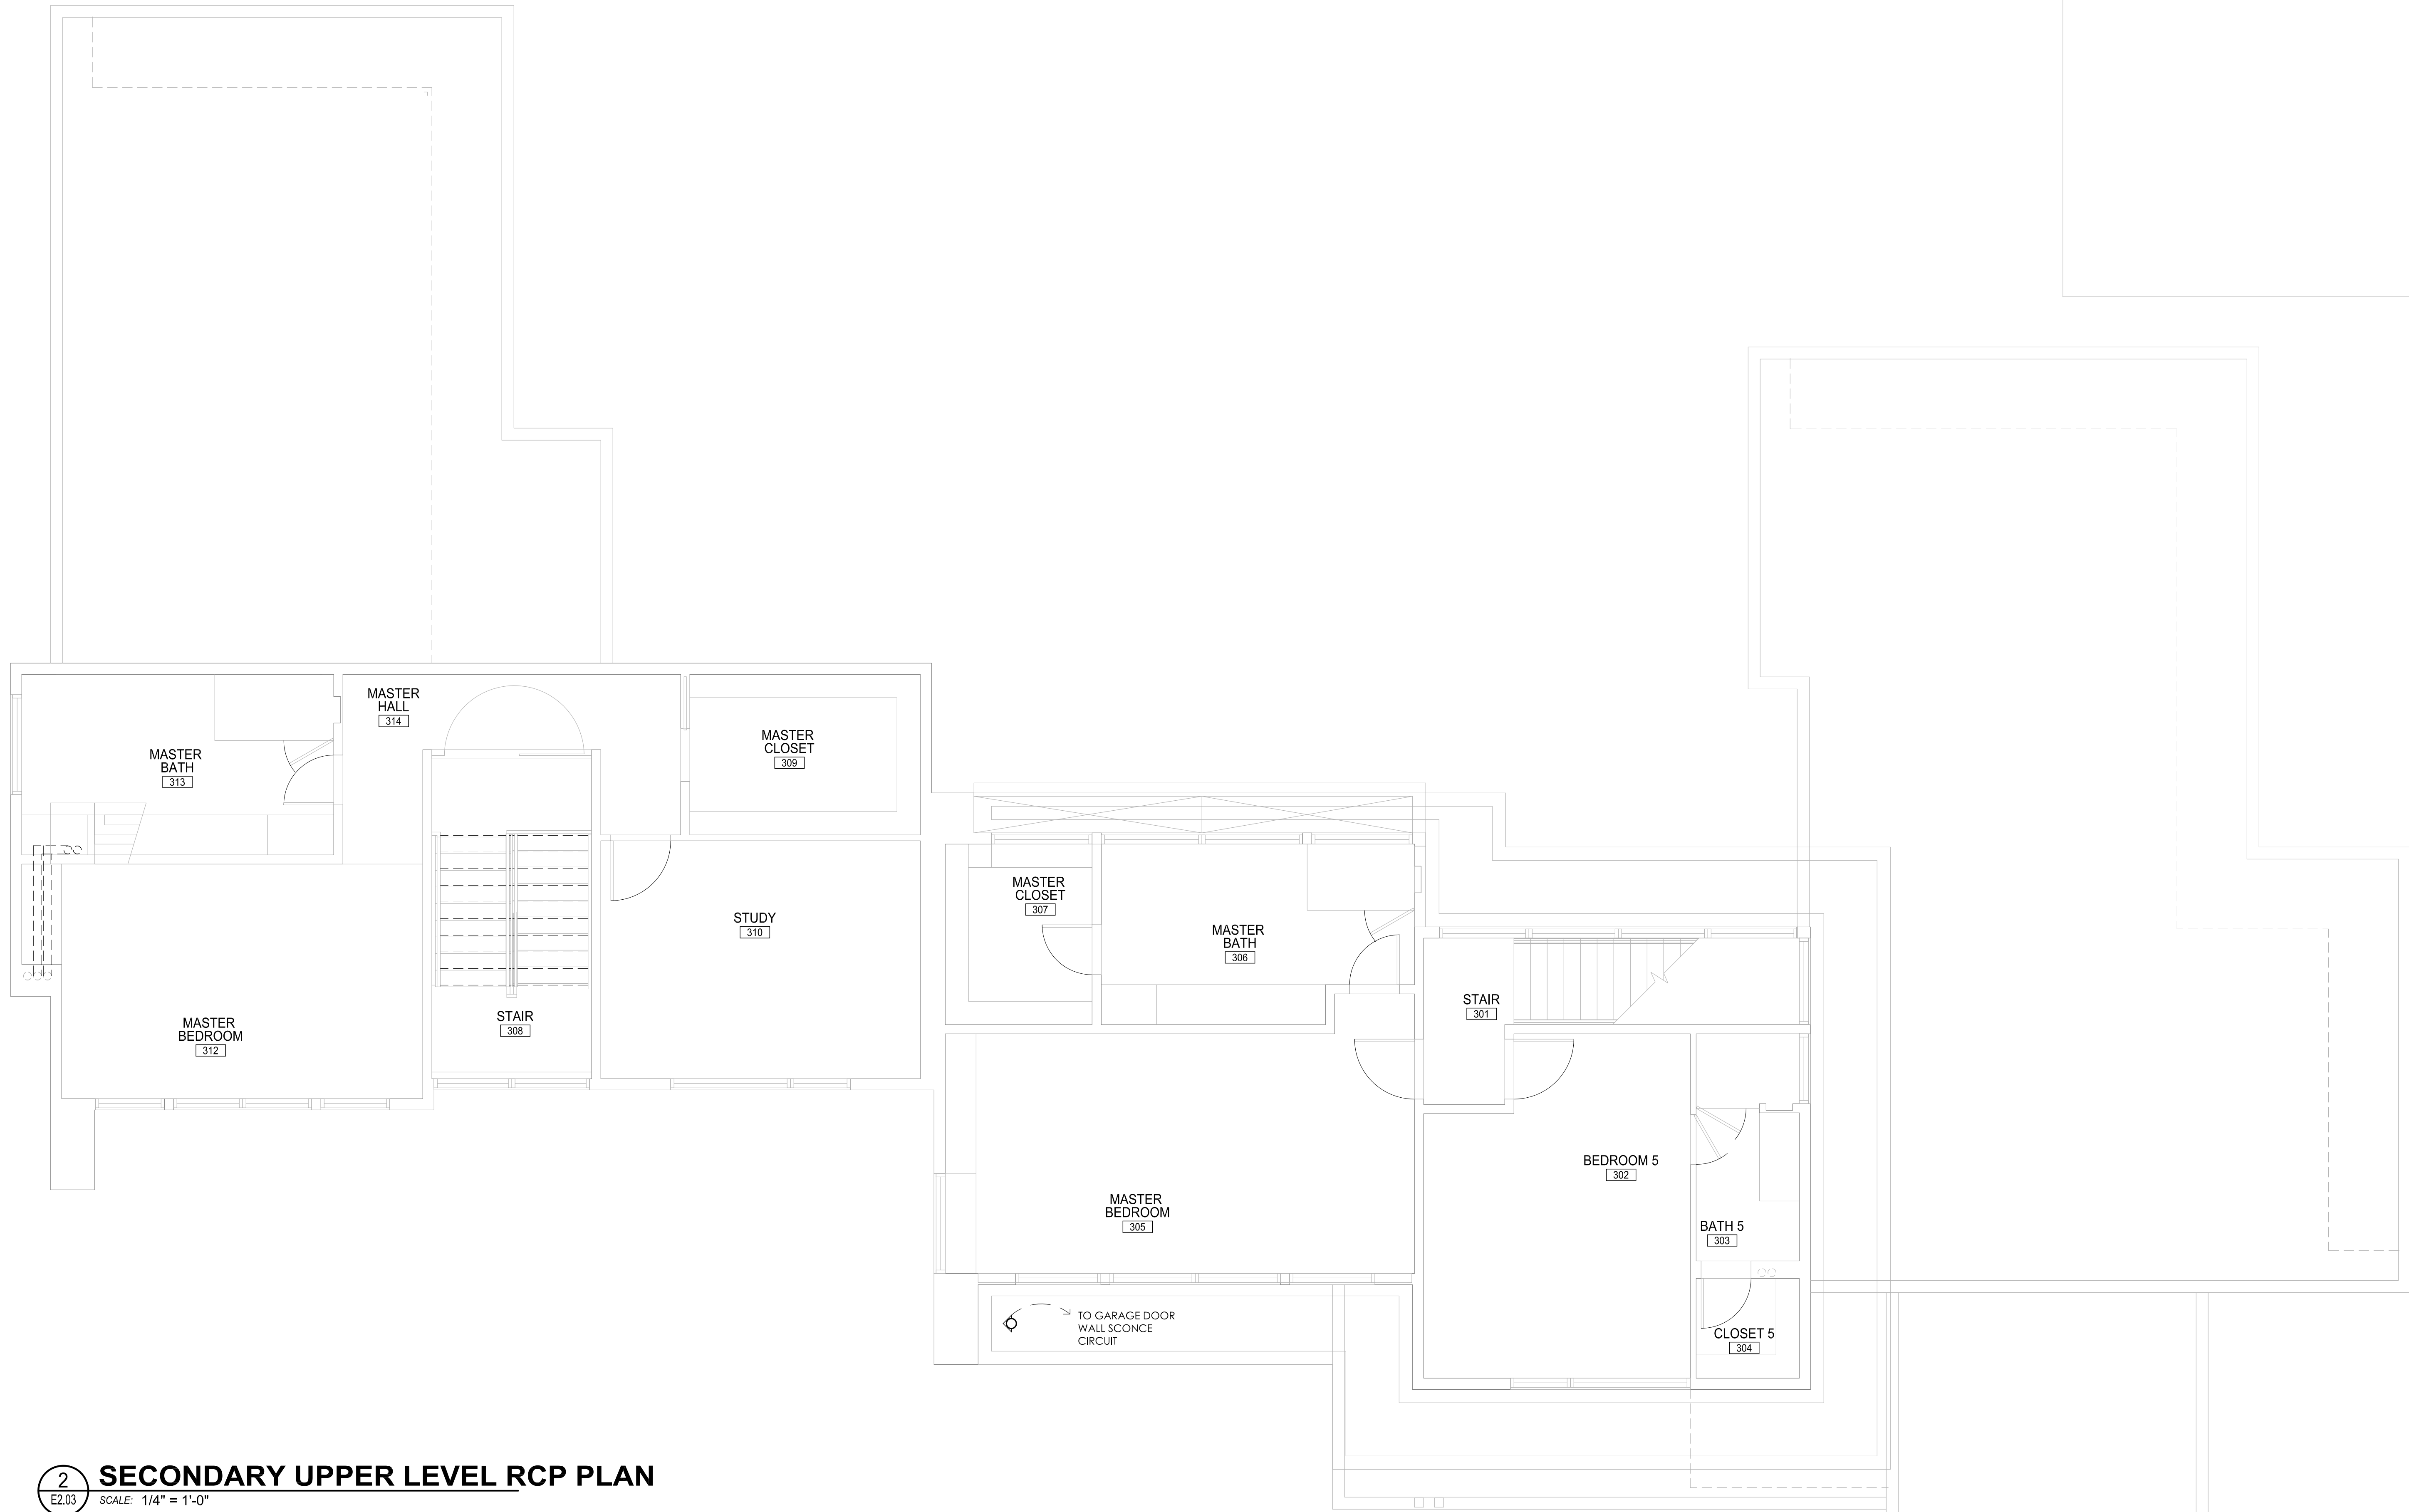

2
E2.03

SECONDARY UPPER LEVEL RCP PLAN

SCALE: 1/4" = 1'-0"

GENERAL ELECTRICAL NOTES:

- 1) ALL RECEPTACLES IN KITCHEN TO BE GFI PROTECTED. THIS INCLUDES RECEPTACLES IN ISLANDS.
- 2) ALL RECEPTACLES AT BATHROOM COUNTERTOPS TO BE GFI PROTECTED.
- 3) ALL EXTERIOR RECEPTACLES TO BE GFI PROTECTED, AND HAVE WEATHERPROOF COVERS.
- 4) SMOKE DETECTORS TO BE INTERCONNECTED PER IRC CODE
- 5) ALL RECESSED CANS IN ROOF TO BE SEALED AIR-TIGHT
- 6) LOW VOLTAGE INTEGRATION SYSTEM THROUGHOUT HOUSE
- 7) COORDINATE ALL WINDOW SHADE POWER LOCATIONS WITH ARCHITECT
- 8) MINIMUM 75% OF NEW LIGHTING TO BE HIGH EFFICIENCY PER CURRENT IECC
- 9) BUBBLE COVERS ARE REQUIRED ON ALL EXTERIOR OUTLETS
- 10) MINIMUM OF TWO SMALL APPLICANT BRANCH CIRCUIT IN KITCHEN
- 11) ALL BRANCH CIRCUITS THAT SUPPLY 120-VOLT, SINGLE-PHASE, 15 AND 20 AMPERE OUTLETS INSTALLED IN FAMILY ROOMS, LIVING ROOMS, DINING ROOMS, PARLORS, LIBRARIES, DEN'S, BEDROOMS, SUNROOMS, REC ROOMS, CLOSETS, HALLWAYS AND SIMILAR ROOMS OR AREAS SHALL BE PROTECTED BY A COMBINATION TYPE ARC-FAULT CIRCUIT INTERRUPTER INSTALLED TO PROVIDE PROTECTION OF THE BRANCH CIRCUIT PER CURRENT IRC
- 12) ALL T.V. LOCATIONS AND HEIGHTS TO BE COORDINATED WITH OWNER A/V SPECS.
- 13) NEW SECURITY SYSTEM TO BE INSTALLED
- 14) LED STRIP LIGHTING TO BE NO GREATER THAN 3000K. PROVIDE SUBMITTAL FOR APPROVAL

ELECTRICAL KEY:

⊙	PENDANT LIGHT	\$	SWITCH
⊙	DIRECTIONAL LIGHT	\$ ^{FP}	KEY PAD SWITCH
⊙	CEILING MOUNTED LIGHT	\$ ¹	MULTIPLE SWITCH
⊙	WALL MOUNTED LIGHT	\$ ¹⁰	DIMMER SWITCH
⊙	WALL MOUNTED SCONCE	⊕	DUPLEX RECEPTACLE
⊙	RECESSED CEILING LIGHT	⊕	HALF SWITCHED DUPLEX RECEPTACLE
⊕	MONOPONT LIGHT	⊕	GROUND FAULT DUPLEX RECEPTACLE
⊕	RECESSED WALL LIGHT	⊕	QUAD RECEPTACLE
⊕	UNDERCABINET LED STRIP LIGHT	⊕	THERMOSTAT
⊕	LED LIGHT	⊕	SPECIAL DEVICE OUTLET
⊕	LED STRIP LIGHTING	⊕	DRAPERY MOTOR
⊕	SPECIALTY PENDANT	⊕	DUPLEX FLOOR RECEPTACLE
⊕	TRACK LIGHT	⊕	CATEGORY 5E CABLE
⊕	DECORATIVE WALL MOUNT	⊕	2 CATEGORY 5E CABLES
⊕	STAKE MOUNTED LANDSCAPE LIGHT	⊕	2 RG6 COAXIAL
⊕	PIER MOUNTED LIGHT	⊕	STRUCTURED CABLE (2 CAT 5E & 2 RG6 COAX)
⊕	SMOKE DETECTOR	⊕	TELEPHONE OUTLET
⊕	SPEAKER	⊕	CAMERA
⊕	WALL MOUNTED EXHAUST FAN		
⊕	BATHROOM EXHAUST FAN		
⊕	JUNCTION BOX		



1
E2.03

PRIMARY UPPER LEVEL RCP PLAN

SCALE: 1/4" = 1'-0"

FIXTURE NOTES:

- A** WALL SCONCE BY TECH LIGHTING
TAKES TO WALL
LED, BRONZE FINISH
(FIXTURE HAS FULL CUT-OFF)
- B** LOW WALL LIGHT BY WAC LIGHTING
W/LED 100-C-SS (STAINLESS STEEL FINISH)
LED
(FIXTURE HAS FULL CUT-OFF)
- C** RECESSED CAN LIGHT
(FIXTURE HAS FULL CUT-OFF)

LOT 2, BLOCK 6, VAIL VILLAGE FILING 7

1012 EAGLES NEST DUPLEX

1012 EAGLES NEST CIRCLE, VAIL, COLORADO

ISSUED FOR:	DATE:
TOV CONCEPTUAL REVIEW	6.25.18
UTILITY VERIFICATION	6.28.18
TOV DRB FINAL REVIEW	8.13.18

© 2018 MICHAEL SUMAN ARCHITECT, LLC. ALL RIGHTS RESERVED.

SCALE: 1/4" = 1'-0"

DRAWN: MDS

PROJECT #: 1705
SHEET TITLE: ELECTRICAL

E2.03

SUMAN
ARCHITECTS

141 East Meadow Drive
Suite 211
Vail, CO 81657
970.471.4122
michael@sumanarchitects.com



